



ELECTRICAL LEGEND	
PLAN SYMBOL	DESCRIPTION
— A	18" LED FIXTURE UNDER-CABINET SURFACE MOUNT
⊙ B	SURFACE MOUNT FIXTURE
⊙ C	WALL-MOUNT VANITY FIXTURE
⊙ D	WALL-MOUNT EXTERIOR LIGHT
○ E	LED PENDANT FIXTURE
⊙ F	PENDANT-MOUNT FIXTURE (W/ FAN J-BOX)
○ G	LED RECESSED WATER-RESISTANT CAN FIXTURE
⊙ H	COMBO LIGHT/HEATER/FAN UNIT
⊙ J	WALL-MOUNT INTERIOR LIGHT
▭	ELECTRICAL PANEL - SURFACE MOUNT
⊕ +?	DUPLEX RECEPTACLE OUTLET +? = HEIGHT FROM FINISHED FLOOR
⊕ +?	QUAD RECEPTACLE OUTLET +? = HEIGHT FROM FINISHED FLOOR
⊕ GFCI	RECEPTACLE OUTLET GROUND FAULT INTERRUPTER
⊕ ?V	SPECIAL-PURPOSE OUTLET - RATING AS INDICATED
\$	LIGHT SWITCH
\$ <sub>3</sub>	3-WAY LIGHT SWITCH
▼	PHONE
▽	DATA PORT
H TV	CABLE/SATELLITE
▭	RETURN REGISTER - SIZE TBD
▭	12" X 12" SUPPLY REGISTER
▭	EXHAUST FAN

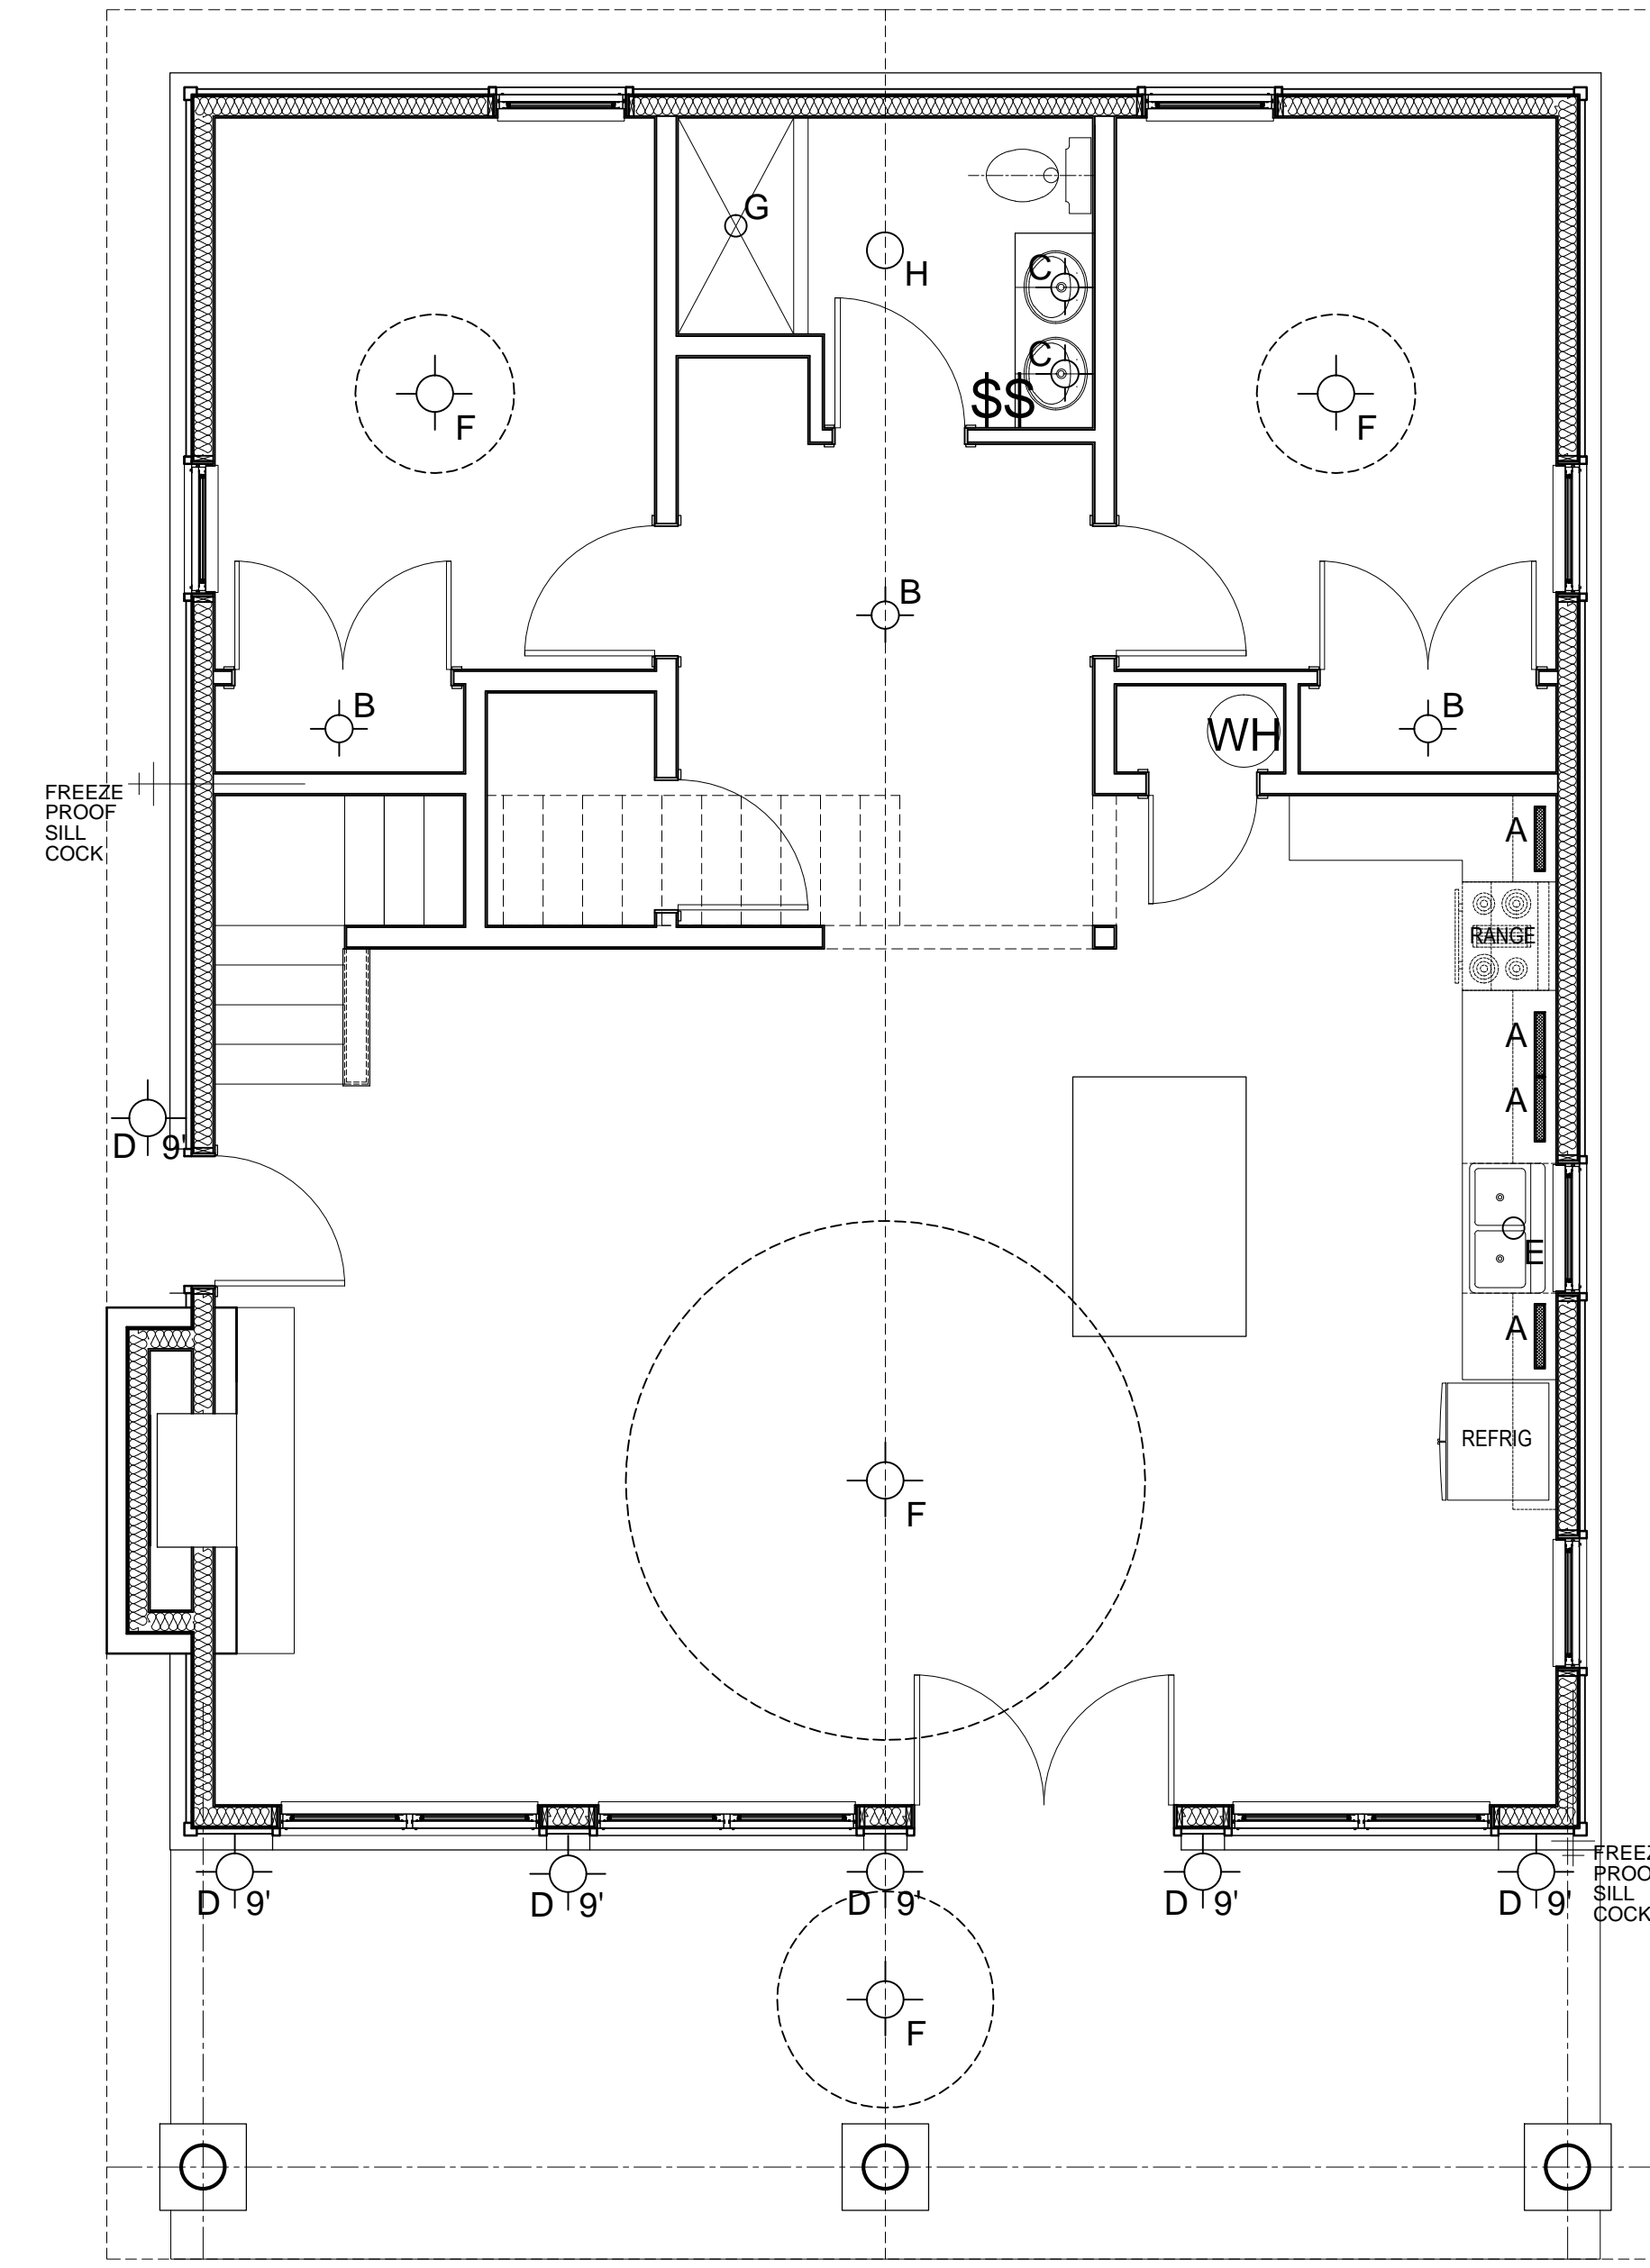

1 2-BED + LOFT CABIN - 1ST FLOOR LIGHTING PLAN  
SCALE: 1/4"=1'-0"

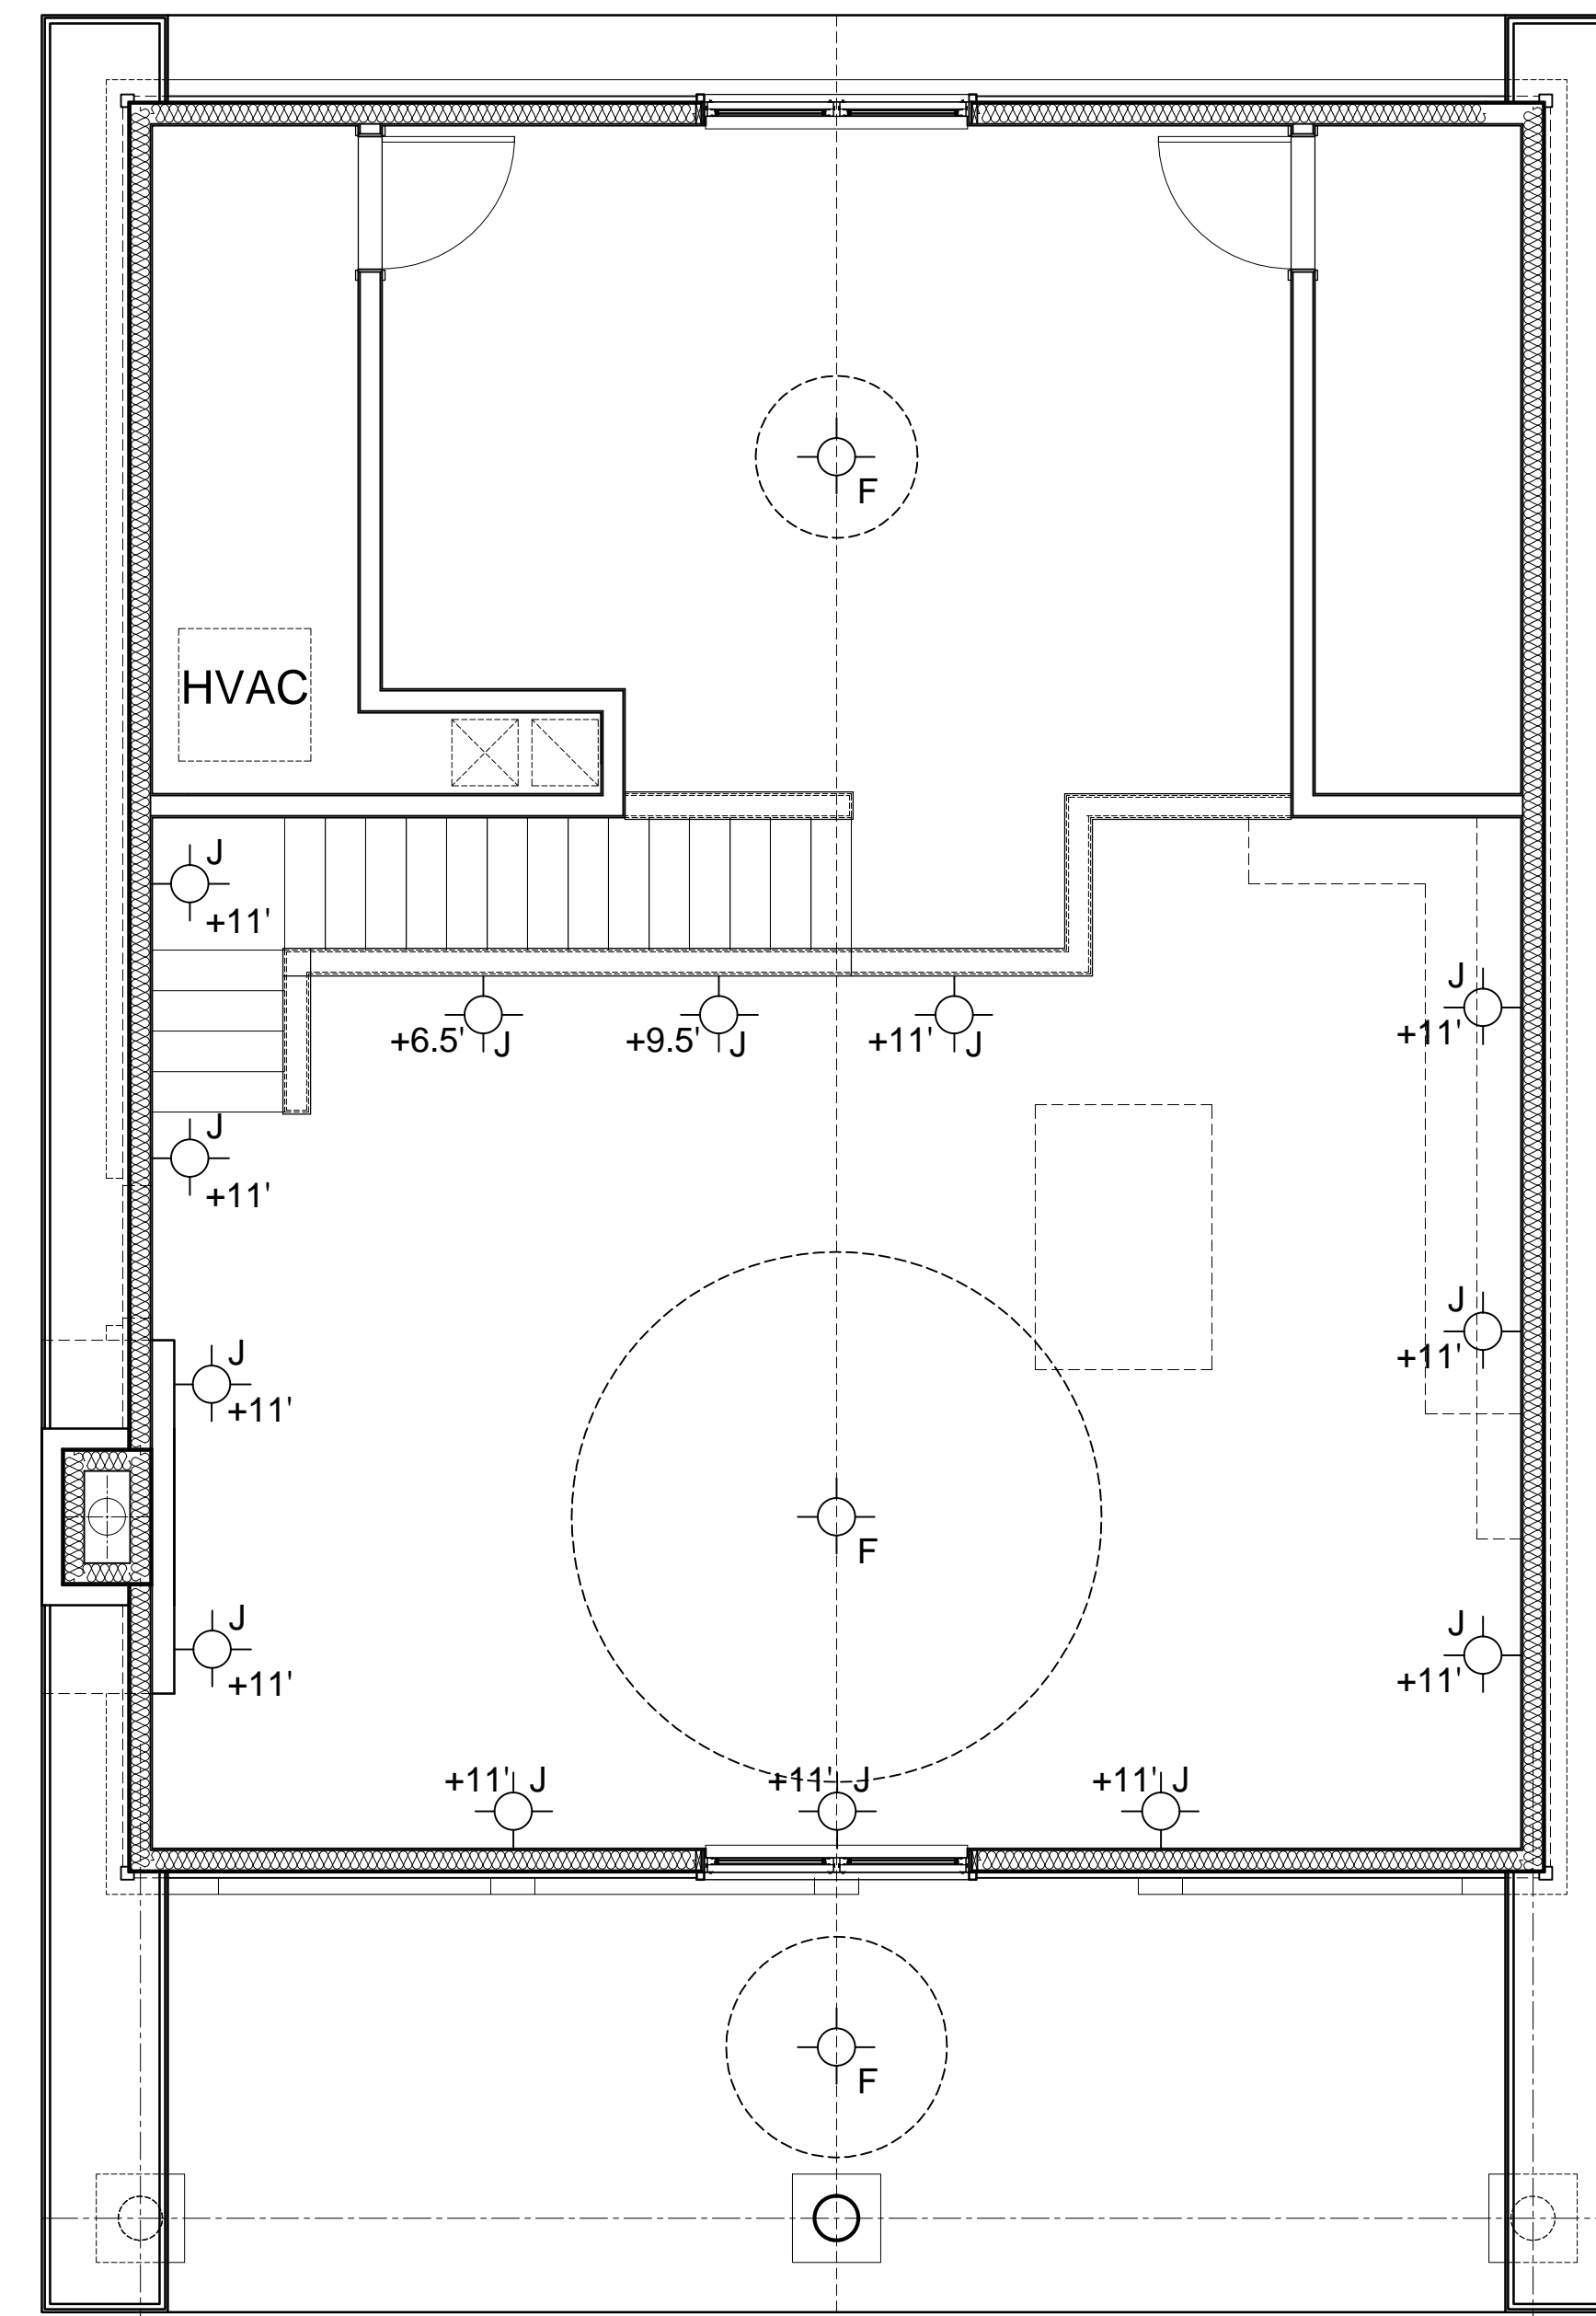

2 2-BED + LOFT CABIN - 2ND FLOOR LIGHTING PLAN  
SCALE: 1/4"=1'-0"



10035 N. 177TH EAST AVE.  
OWASSO, OK 74055-7841  
918-798-5979  
joe@bbkcae.com

3600 SUNVALLEY DR.  
NORMAN, OK 73026-0632  
405-821-2137  
egb@bbkcae.com



CONSULTANTS:

REVISED FOR  
CONSTRUCTION  
06.23.2023

THESE DRAWINGS ARE THE PROPERTY OF ED G. BISHOP, ARCHITECT AIA AND SHALL BE F.O.C. UNAUTHORIZED REPRODUCTION FOR ANY PURPOSE IS AN INFRINGEMENT UPON COPYRIGHT LAWS. VIOLATORS WILL BE SUBJECT TO PROSECUTION TO THE FULLEST EXTENT OF THE LAW.

WRITTEN DIMENSIONS ON THESE DRAWINGS SHALL HAVE PRECEDENCE OVER SCALE DIMENSIONS. CONTRACTORS SHALL VERIFY AND BE RESPONSIBLE FOR ALL DIMENSIONS AND CONDITIONS ON THE JOB AND THIS OFFICE MUST BE NOTIFIED OF ANY VARIATION FROM THE DIMENSIONS AND CONDITIONS SHOWN BY THESE DRAWINGS. NO CHANGE ORDERS WILL BE ISSUED FOR CHANGES REQUIRED IN THE FIELD AFTER CONSTRUCTION HAS COMMENCED UNLESS SPECIFICALLY AUTHORIZED BY THE OWNER. ©2015 BBKAE.

REVISIONS:	DATE:
△	-
△	-
△	-
△	-
△	-
△	-

RELEASED FOR:	DATE:
<input type="checkbox"/> PRELIMINARY ONLY	-
<input type="checkbox"/> BIDDING	-
<input type="checkbox"/> PERMITS	-
<input type="checkbox"/> CONSTRUCTION	-

PROJECT NO: CHEROKEE LAKE CABINS  
CAD DWG FILE:  
DRAWN BY: gdw  
CHECKED BY: egb



CHEROKEE NATION  
SALLISAW CREEK  
STATE PARK CABINS  
SALLISAW, OKLAHOMA

2-BED + LOFT  
CABIN  
LIGHTING PLANS

E102

SHEET NO. 4