



10035 N. 177TH EAST AVE.  
OWASSO, OK 74055-7841  
918-798-5979  
joe@bbkcae.com

3600 SUNVALLEY DR.  
NORMAN, OK 73026-0632  
405-821-2137  
egb@bbkcae.com



CONSULTANTS:

**REVISED FOR  
CONSTRUCTION  
06.23.2023**

THESE DRAWINGS ARE THE PROPERTY OF ED G. BISHOP, ARCHITECT AIA AND SHALL BE P.L.C. UNAUTHORIZED REPRODUCTION FOR ANY PURPOSE IS AN INFRINGEMENT UPON COPYRIGHT LAWS. VIOLATORS WILL BE SUBJECT TO PROSECUTION TO THE FULLEST EXTENT OF THE LAW.  
WRITTEN DIMENSIONS ON THESE DRAWINGS SHALL HAVE PRECEDENCE OVER SCALE DIMENSIONS. CONTRACTORS SHALL VERIFY AND BE RESPONSIBLE FOR ALL DIMENSIONS AND CONDITIONS ON THE JOB AND THIS OFFICE MUST BE NOTIFIED OF ANY VARIATION FROM THE DIMENSIONS AND CONDITIONS SHOWN BY THESE DRAWINGS. NO CHANGE ORDERS WILL BE ISSUED FOR CHANGES REQUIRED IN THE FIELD AFTER CONSTRUCTION HAS COMMENCED UNLESS SPECIFICALLY AUTHORIZED BY THE OWNER. ©2015 BBKAE.

REVISIONS:	DATE:
▲	-
▲	-
▲	-
▲	-
▲	-
▲	-

RELEASED FOR:	DATE:
<input type="checkbox"/> PRELIMINARY ONLY	-
<input type="checkbox"/> BIDDING	-
<input type="checkbox"/> PERMITS	-
<input checked="" type="checkbox"/> CONSTRUCTION	-

PROJECT NO: CHEROKEE LAKE CABINS  
CAD DWG FILE:  
DRAWN BY: gdw  
CHECKED BY: egb




**CHEROKEE NATION  
SALLISAW CREEK  
STATE PARK CABINS  
SALLISAW, OKLAHOMA**

**4-BED + LOFT  
CABIN  
LIGHTING PLANS**

**E102**


SHEET NO. 4

ELECTRICAL LEGEND	
PLAN SYMBOL	DESCRIPTION
	1X4 LED FIXTURE SURFACE MOUNT
	SURFACE MOUNT FIXTURE
	WALL-MOUNT VANITY FIXTURE
	WALL-MOUNT EXTERIOR LIGHT
	LED PENDANT FIXTURE
	PENDANT-MOUNT FIXTURE (W/ FAN J-BOX)
	LED RECESSED WATER-RESISTANT CAN FIXTURE
	COMBO LIGHT/HEATER/FAN UNIT
	ELECTRICAL PANEL - SURFACE MOUNT
	DUPLEX RECEPTACLE OUTLET
	QUAD RECEPTACLE OUTLET
	RECEPTACLE OUTLET GROUND FAULT INTERRUPTER
	SPECIAL-PURPOSE OUTLET - RATING AS INDICATED
	LIGHT SWITCH
	3-WAY LIGHT SWITCH
	PHONE
	DATA PORT
	CABLE/SATELLITE
	RETURN REGISTER - SIZE TBD
	12" X 12" SUPPLY REGISTER
	EXHAUST FAN

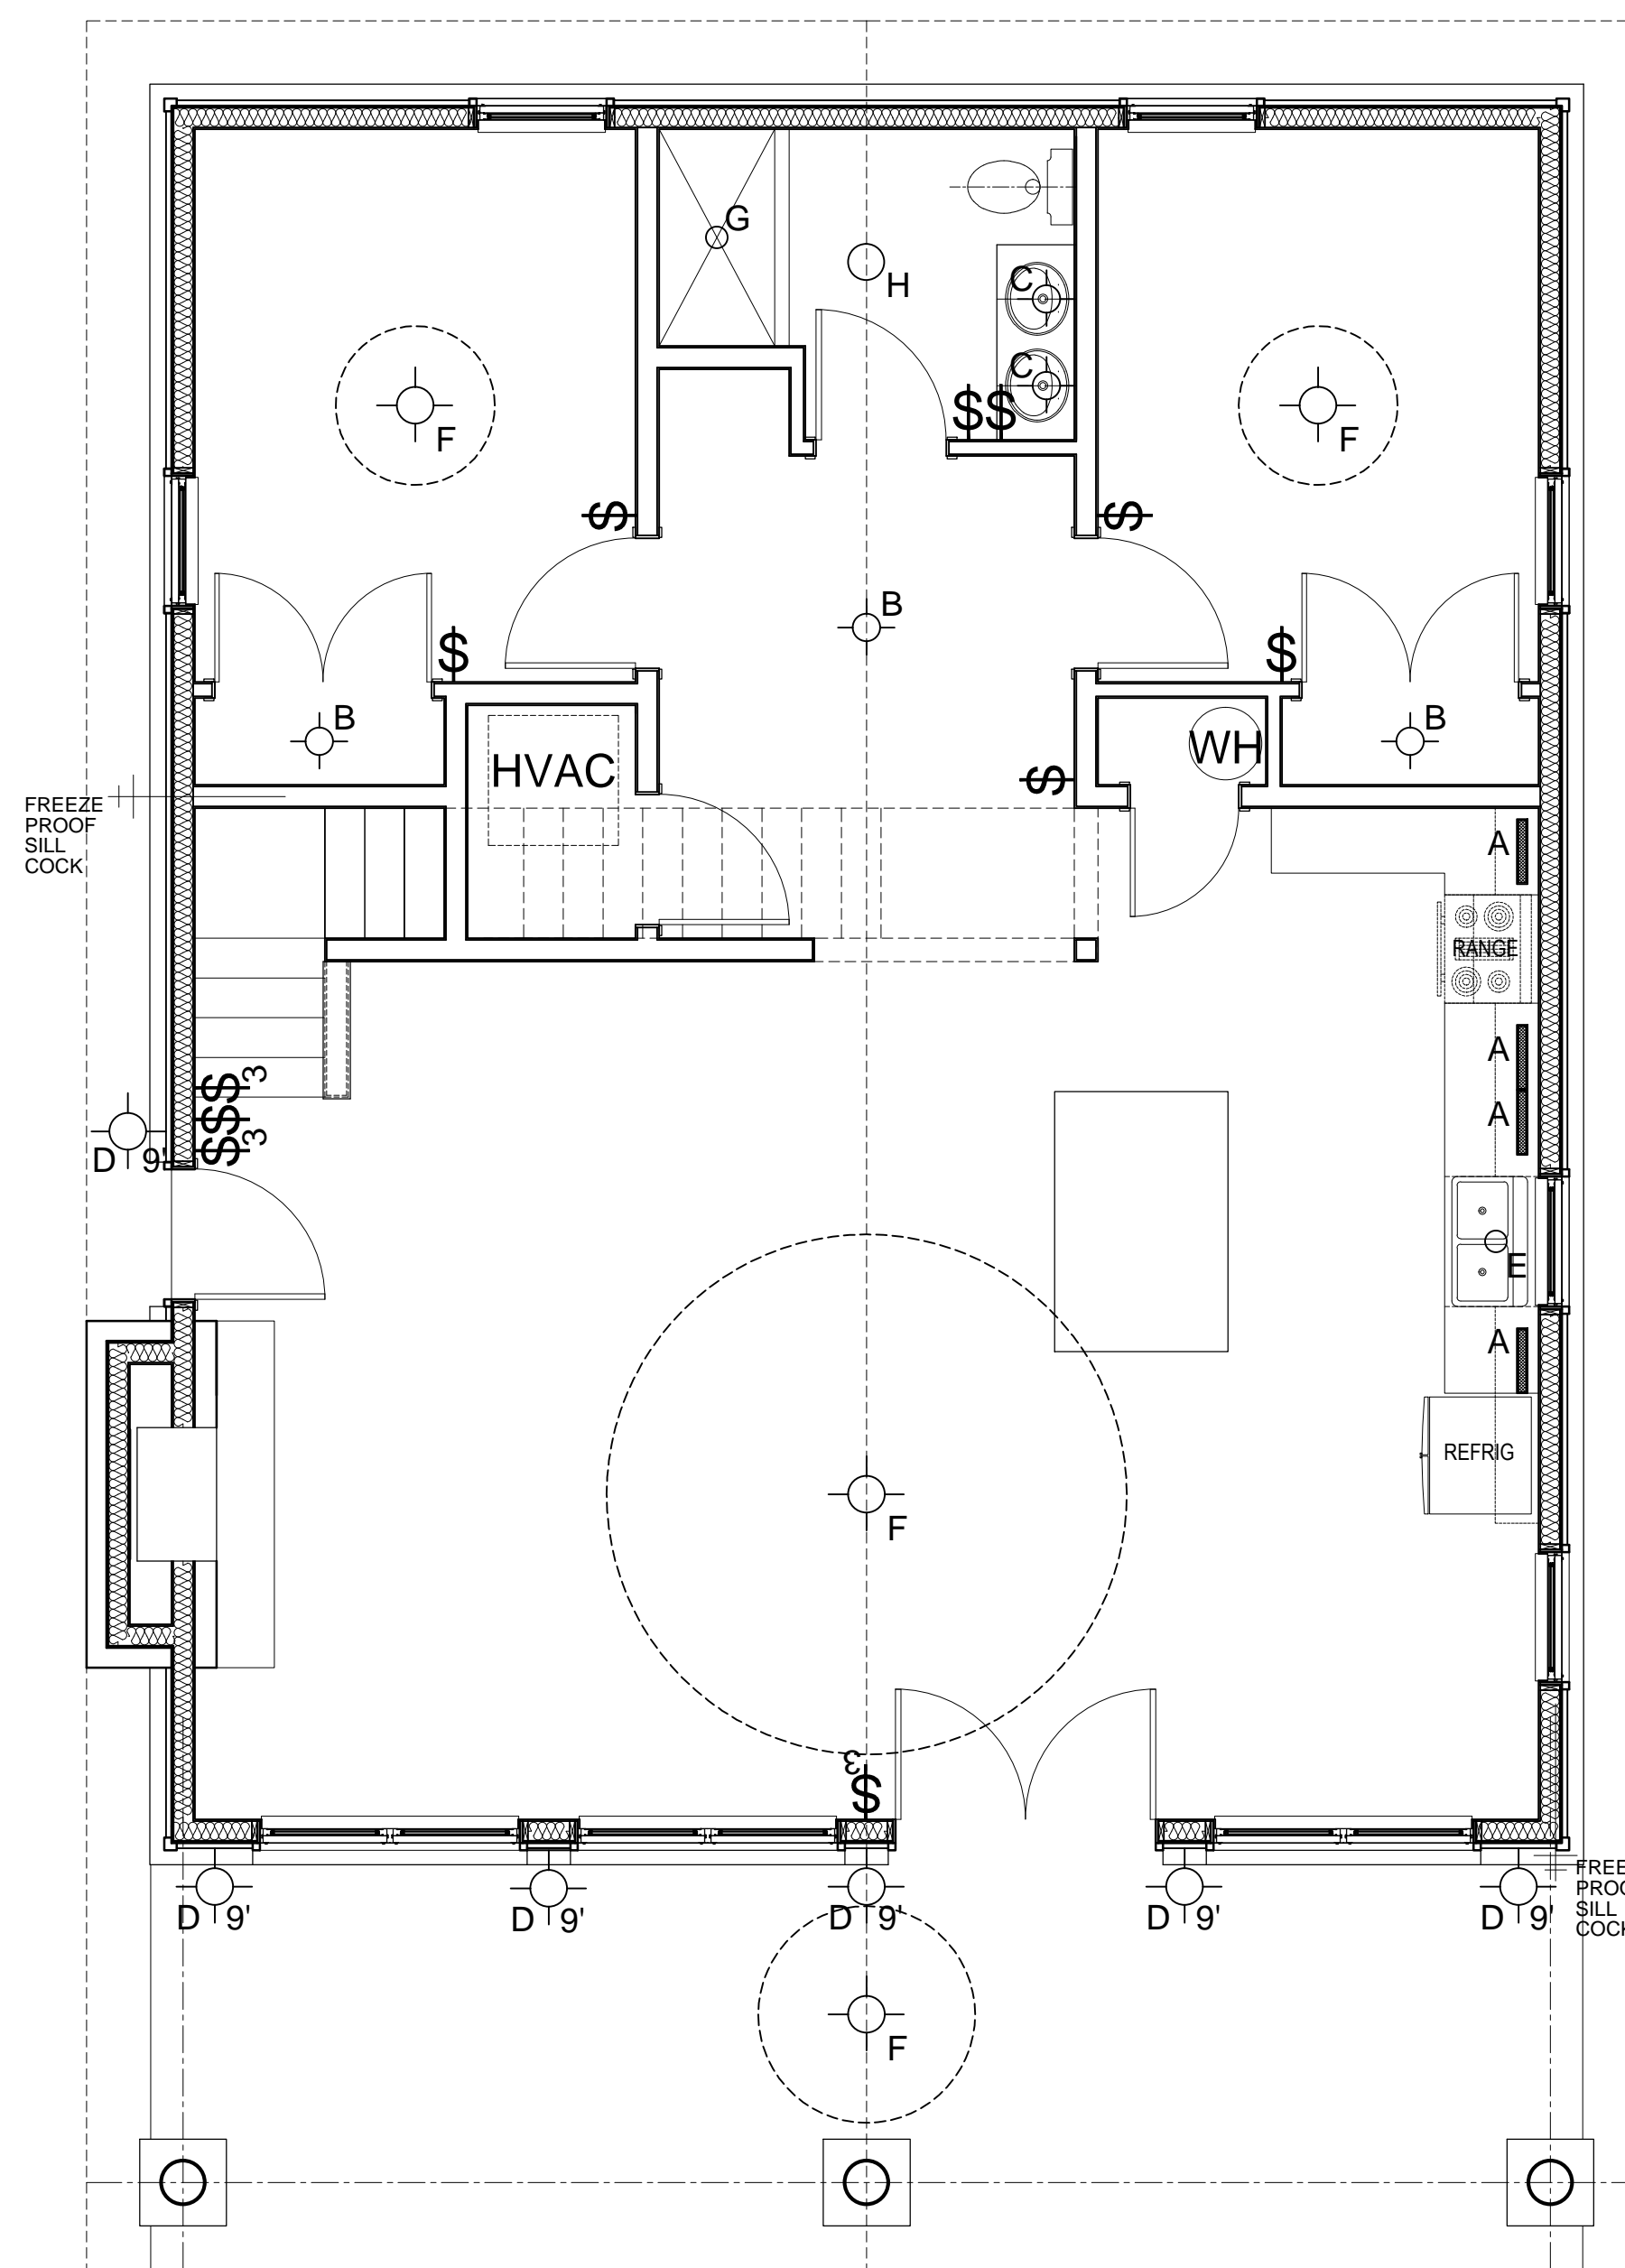

## 1ST FLOOR

**1 4 BED + LOFT CABIN - 1ST FLOOR LIGHTING PLAN**  
SCALE: 1/4"=1'-0"

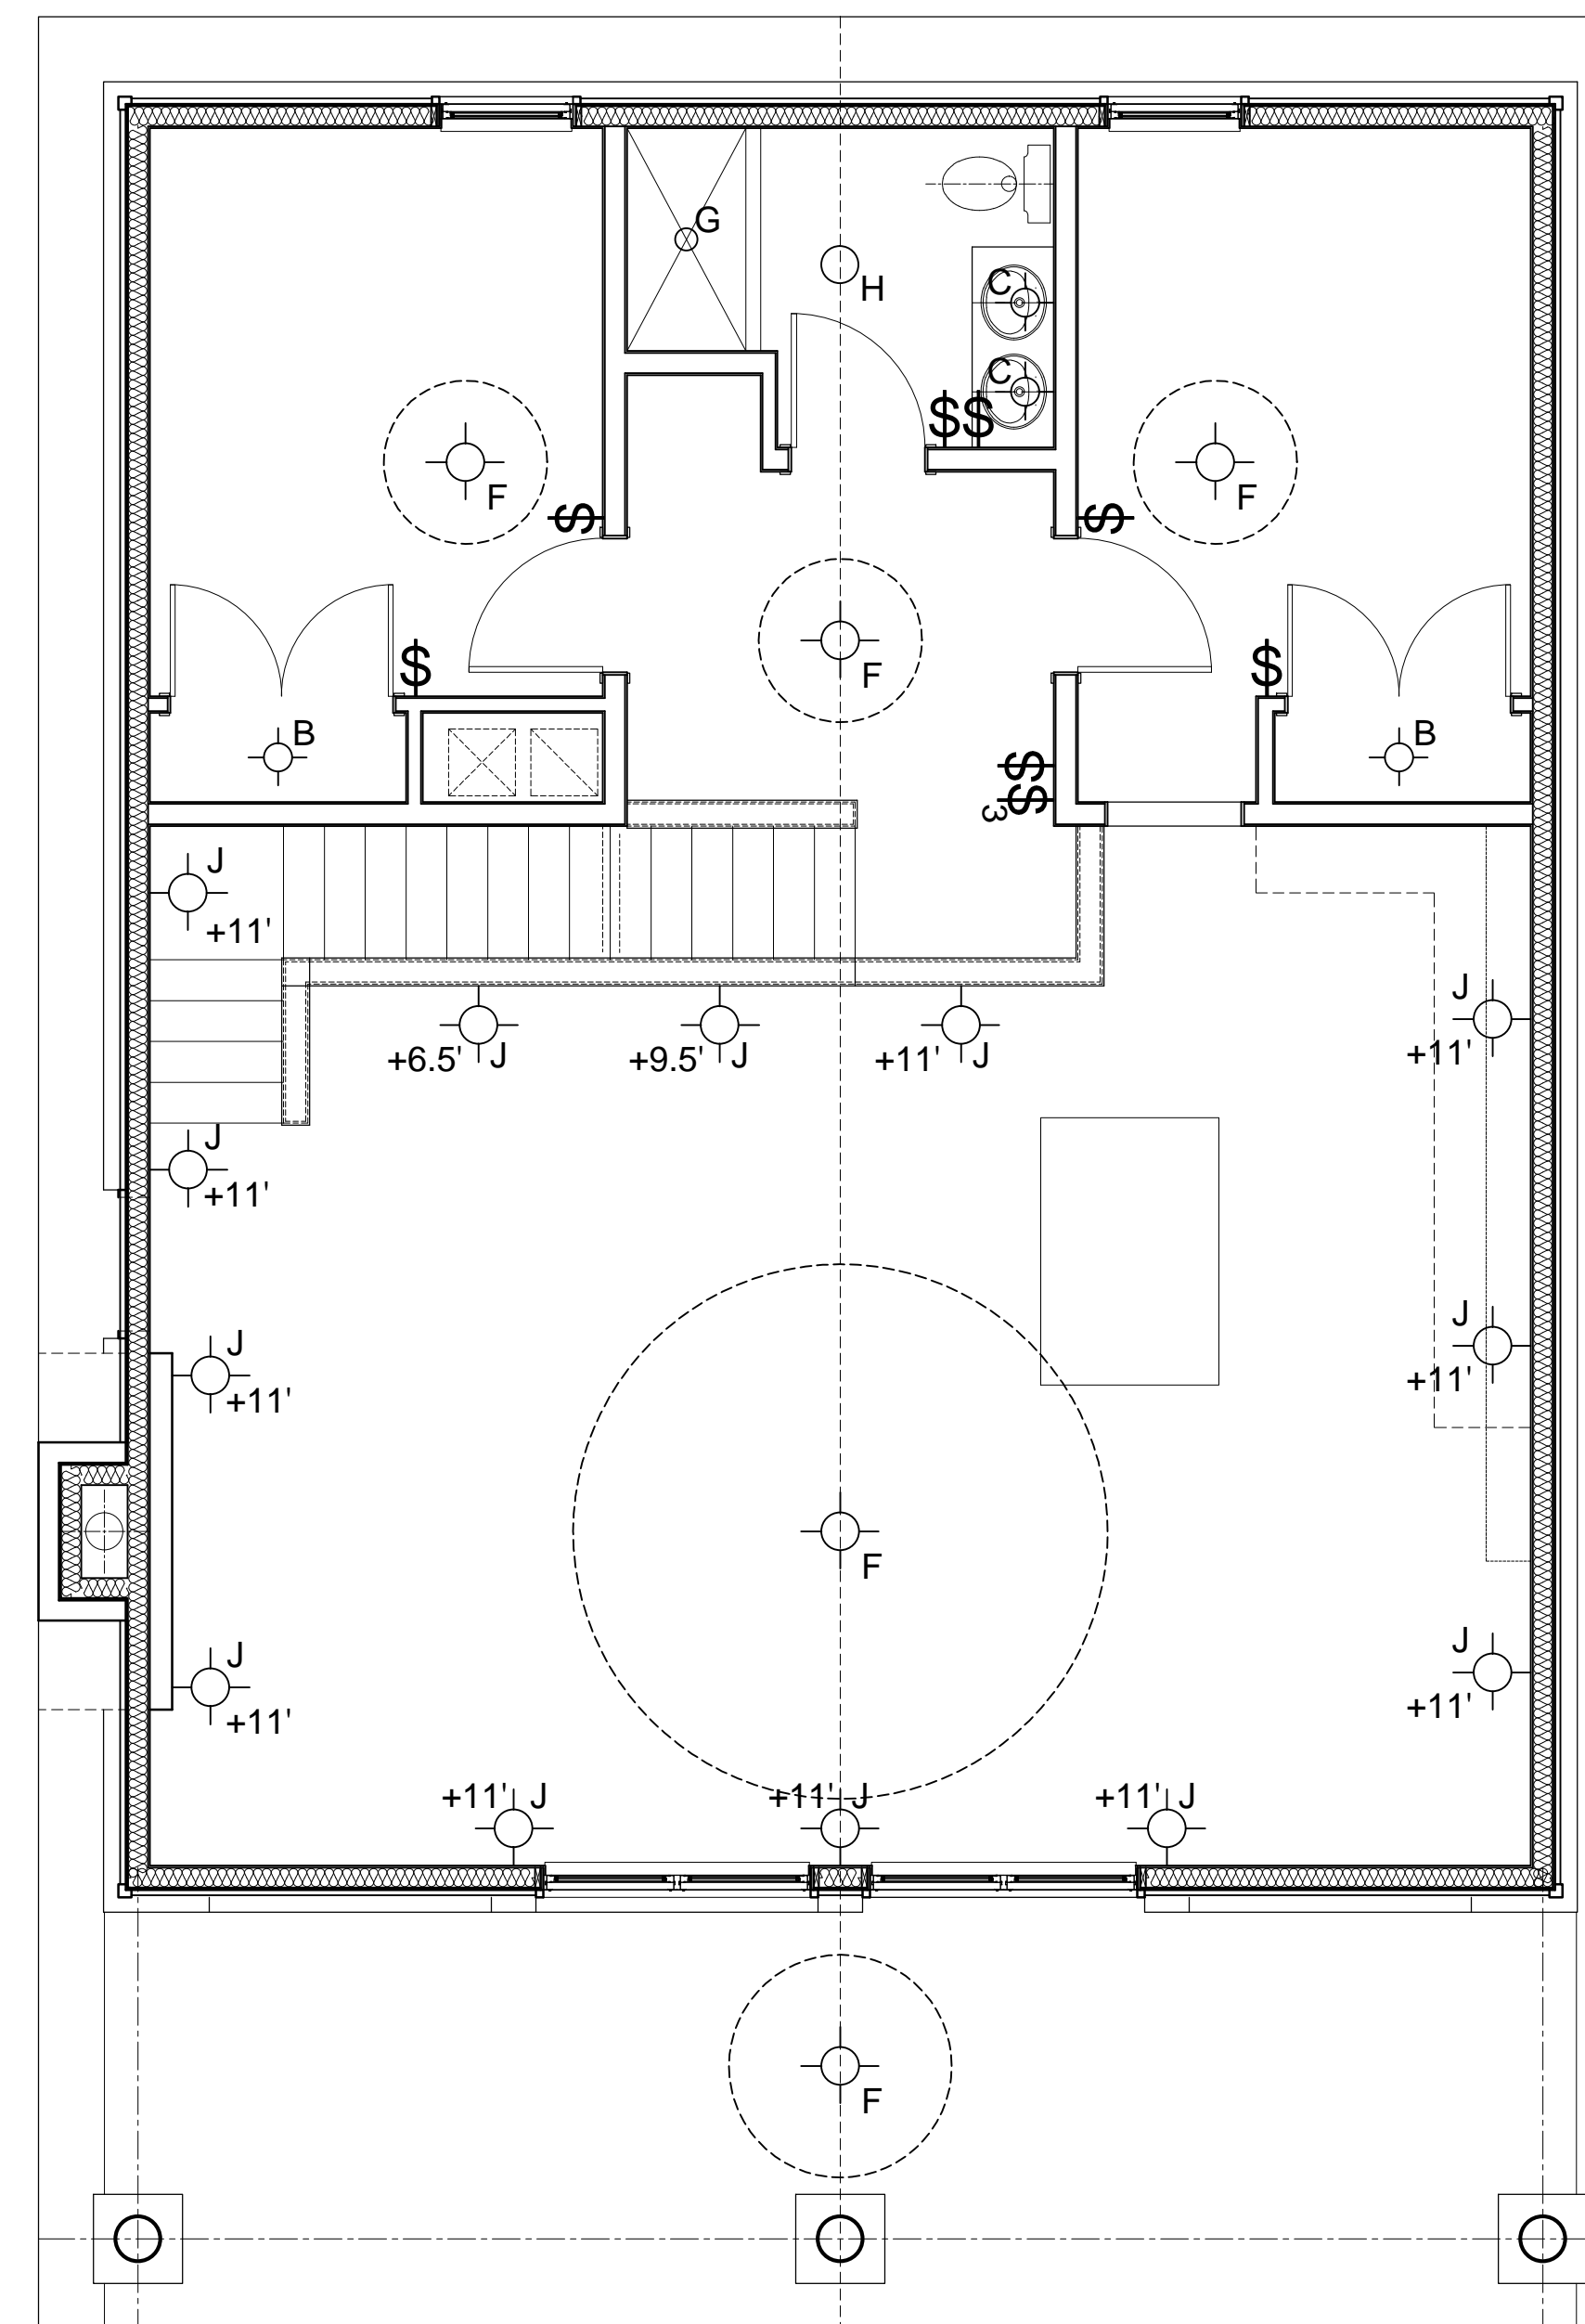

## 2ND FLOOR

**2 4 BED + LOFT CABIN - 2ND FLOOR LIGHTING PLAN**  
SCALE: 1/4"=1'-0"