

PLANS FOR
 2 BEDROOM SHOTGUN STYLE
 ADA WITH LEFT GARAGE
 AND ~~SIDING~~ BRICK EXTERIOR
 1510 SQUARE FOOT

SHEET INDEX

SHEET NO.	DESCRIPTION
A101	TITLE SHEET
A102	FLOOR PLAN
A103	CABINET ELEV./HVAC CLOSET FRAMING
A104	FOUNDATION PLAN
A105	FOUNDATION PLAN DETAILS/WALL SECTION DETAIL
A106	ELEVATIONS - GABLE
M101	HVAC PLANS
P101	WASTE AND VENT PLUMBING PLANS
P102	DOMESTIC WATER PLANS
P103	ISOMETRIC PLUMBING PLAN
E101	ELECTRICAL PLAN

ISSUED FOR CONSTRUCTION
 JUNE 20, 2022

Cherokee Nation
 2 Bedroom Shotgun ADA Left
 Garage Title Sheet
 1510 Square Feet

CLIENT: Cherokee Nation
 Housing Authority

DESIGNED BY:

APPROVED BY:
 CDG




ENGINEER
 KAS Gales Company
 Consulting Engineers
 18772 Harmon Road
 Fayetteville, AR 72704
 Wk. 479.361.9977 Cell 479.422.0763
 Email: carl.d.gales@gmail.com

A101
 SHEET NO.

SCALE
3/8" = 1'

NOTE:
~~SAFE ROOM REABRICATED WITH SEMA
FRAMING~~

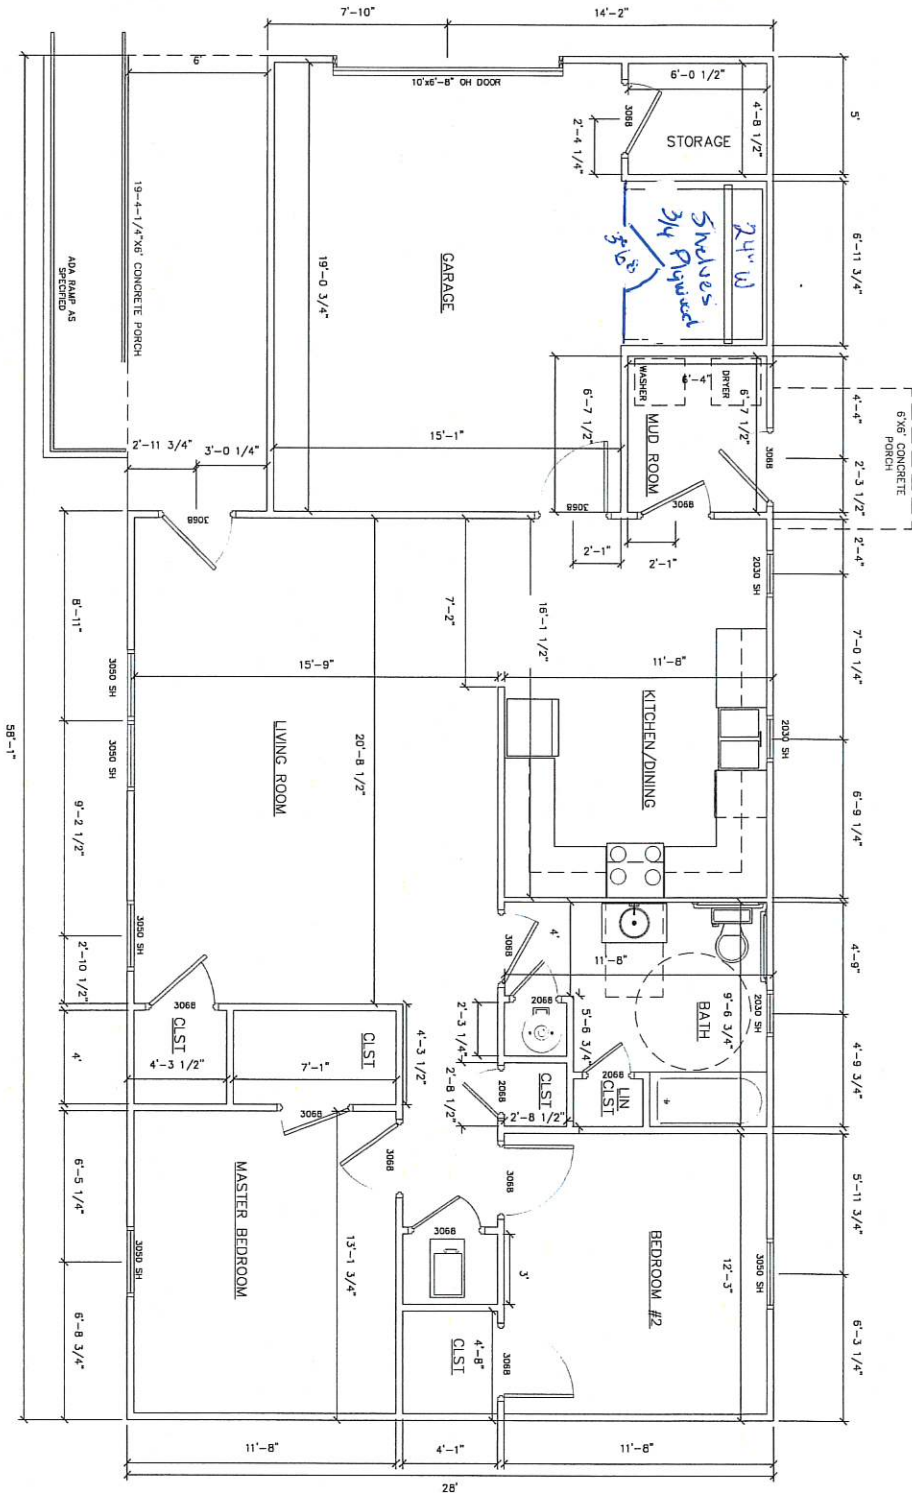

Cherokee Nation
2 Bedroom Shotgun ADA Left
Garage Floor Plan
1510 Square Feet

CLIENT: Cherokee Nation
Housing Authority




ENGINEER
KAS Gales Company
Consulting Engineers
18772 Harmon Road
Fayetteville, AR 72704
Wk. 479.361.9977 Cell 479.422.0763
Email: carl.d.gales@gmail.com


DESIGNED BY:

APPROVED BY:
CDG

A102
SHEET NO.

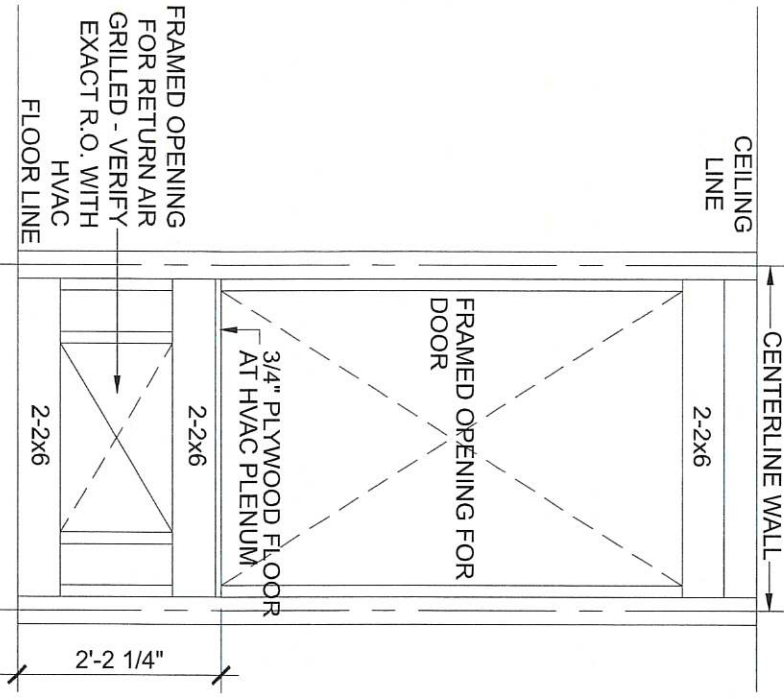

HVAC CLOSET FRAMING
SCALE 1"=1/2"=1'



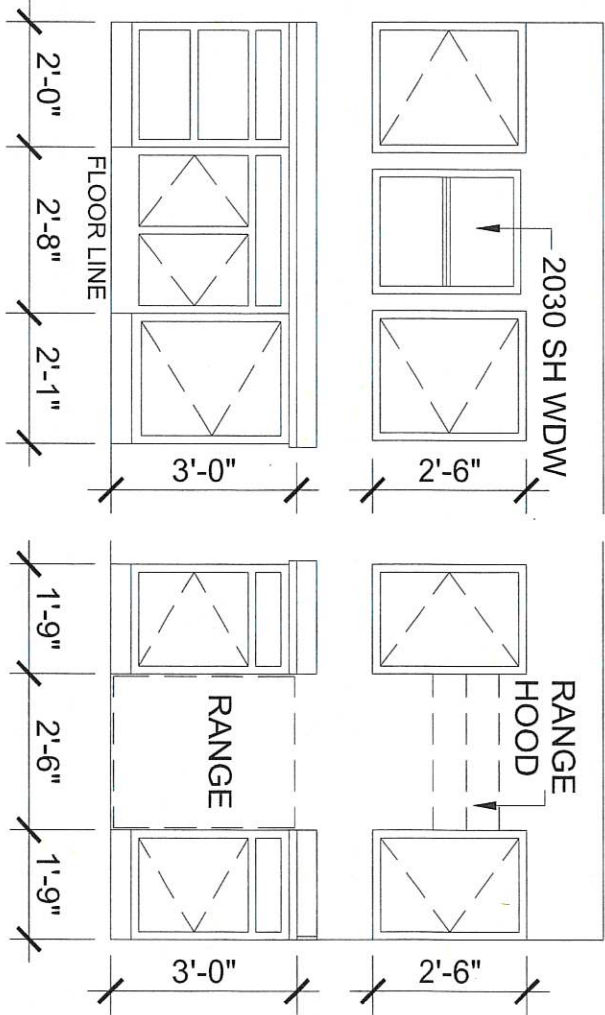



CABINET ELEVATION
SCALE 1"=1/2"=1'

Cherokee Nation 2 Bedroom Shotgun ADA Left Garage Cabinet Elev/HVAC 1510 Square Feet	
CLIENT: Cherokee Nation Housing Authority	
DESIGNED BY:	APPROVED BY: CDG


ENGINEER
KAS Gales Company
Consulting Engineers
18772 Harmon Road
Fayetteville, AR 72704
Wk. 479.361.9977 Cell 479.422.0763
Email: carl.d.gales@gmail.com

A103
SHEET NO.

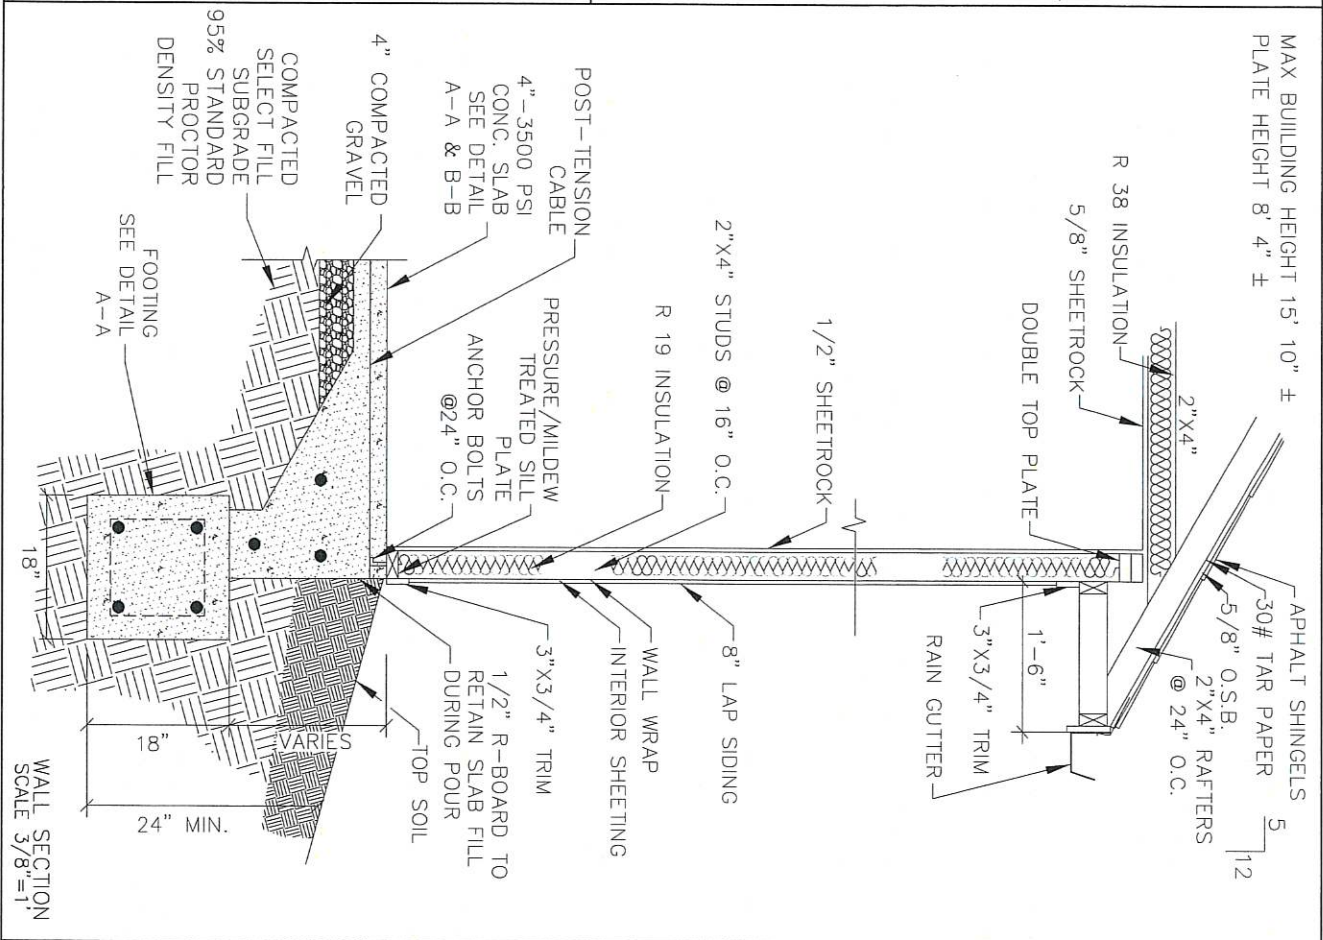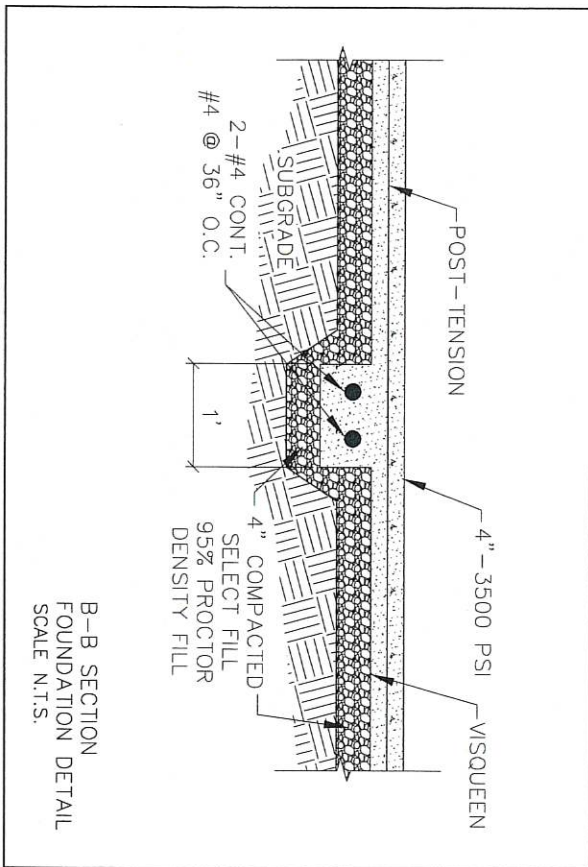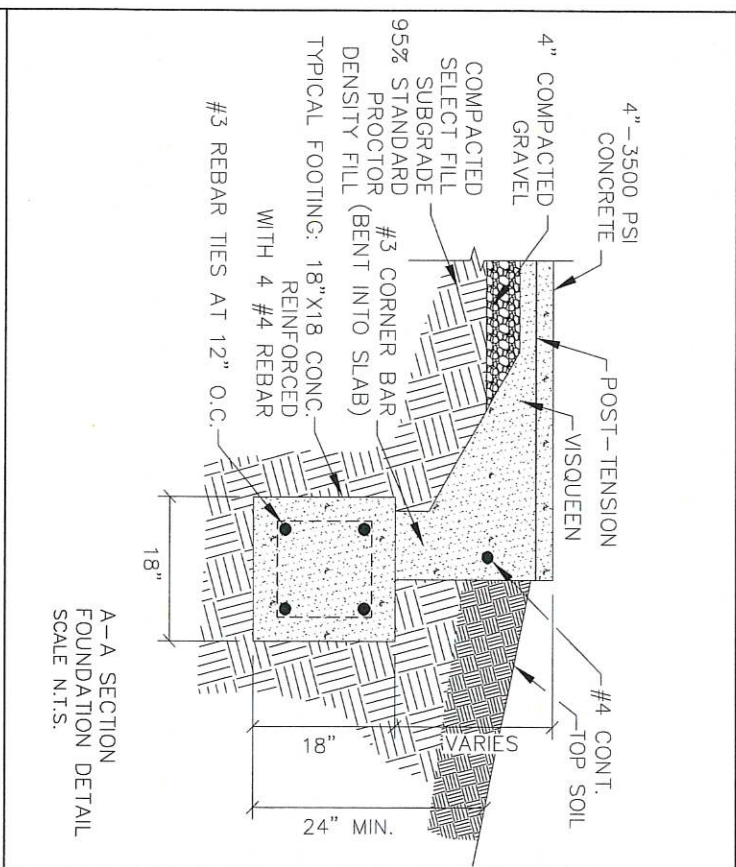


<p>A105 SHEET NO.</p>	<p>Cherokee Nation 2 Bedroom Shotgun ADA Left Garage Foundation Details 1510 Square Feet</p>	 <p>ENGINEER KAS Gales Company Consulting Engineers 18772 Harmon Road Fayetteville, AR 72704 Wk. 479.361.9977 Cell 479.422.0763 Email: carl.d.gales@gmail.com</p>
	<p>CLIENT: Cherokee Nation Housing Authority</p>	
<p>DESIGNED BY:</p>	<p>APPROVED BY: CDG</p>	

BR

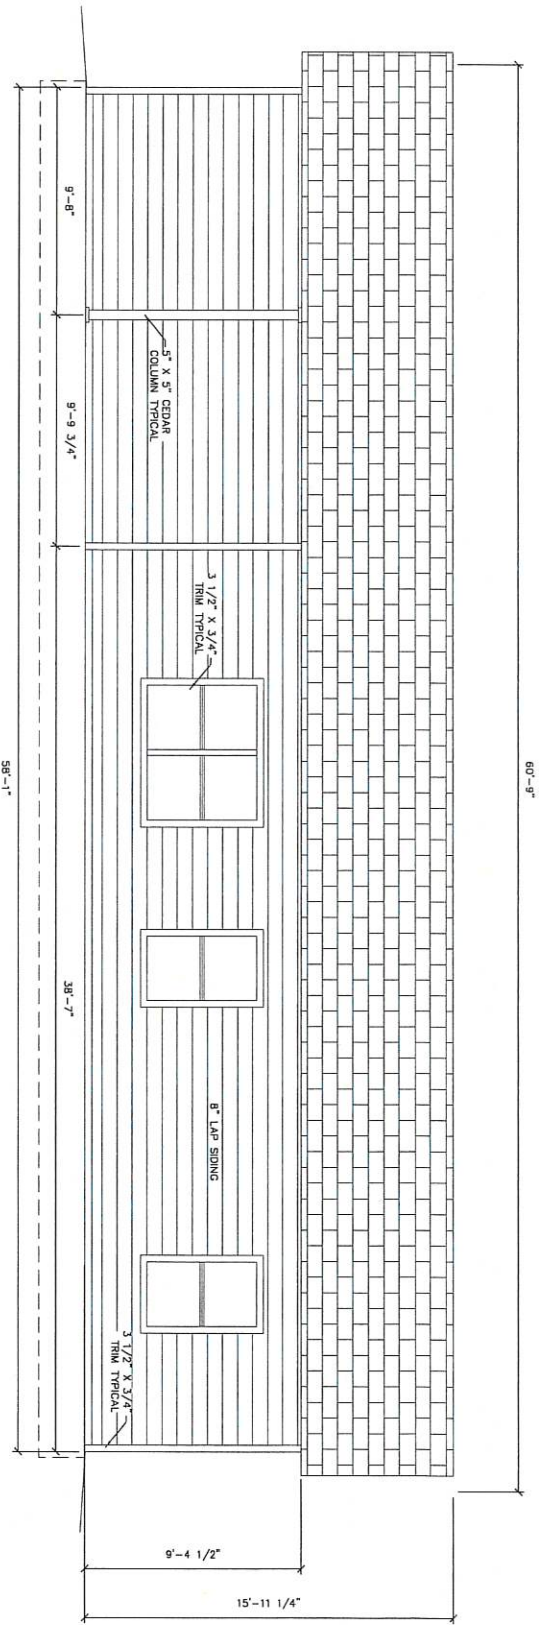

FRONT ELEVATION

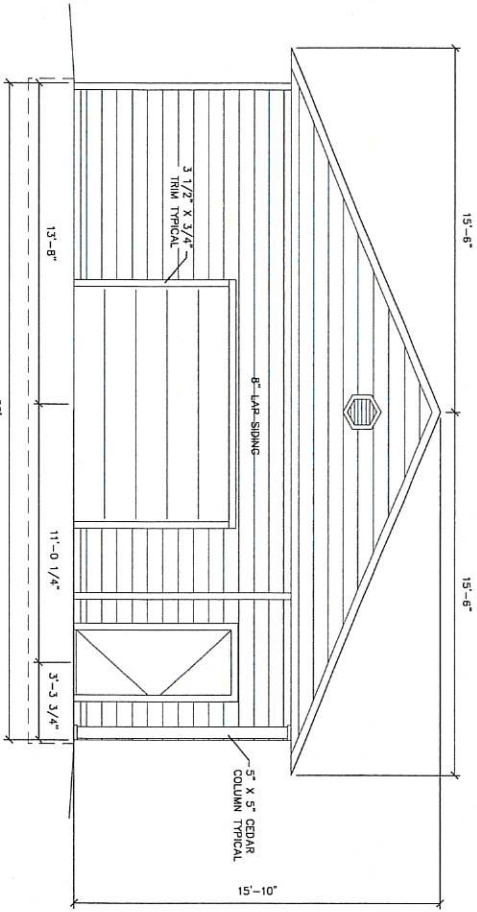

SIDE ELEVATION

SCALE
3/8" = 1'

A106
SHEET NO.

Cherokee Nation
2 Bedroom Shotgun ADA Left
Garage Elevations
1510 Square Feet


CLIENT: Cherokee Nation
Housing Authority

DESIGNED BY:

APPROVED BY:
CDG



ENGINEER
KAS Gales Company
Consulting Engineers
18772 Harmon Road
Fayetteville, AR 72704
Wk. 479.361.9977 Cell 479.422.0763
Email: carl.gales@gmail.com

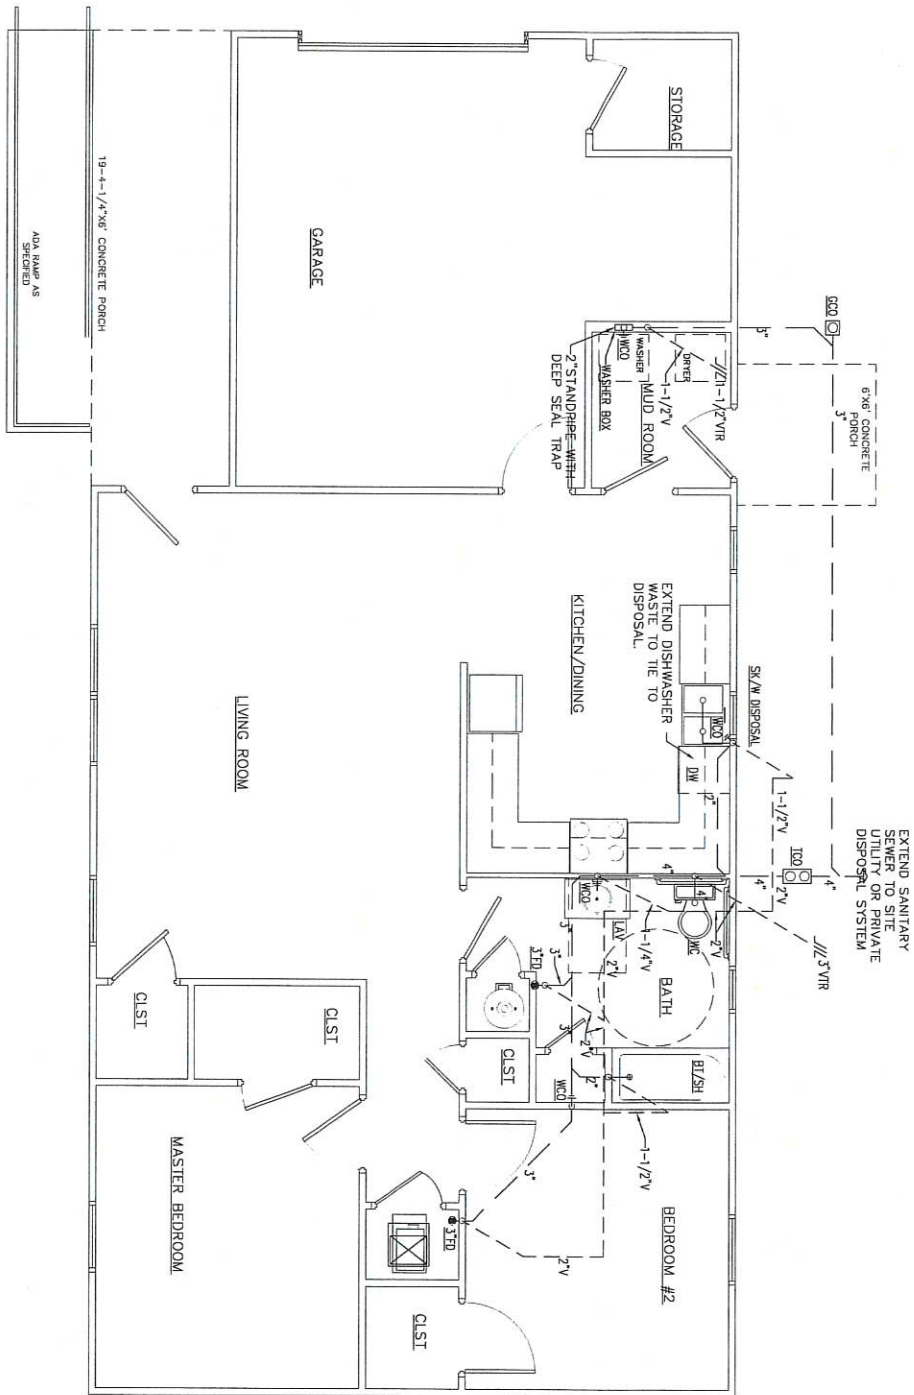

SCALE
3/8" = 1'

P101
SHEET NO.

Cherokee Nation
2 Bedroom Shotgun ADA Left
Garage Waste and Vent
Plumbing Plan
1510 Square Feet


CLIENT: Cherokee Nation
Housing Authority



ENGINEER
KAS Gales Company
Consulting Engineers
18772 Harmon Road
Fayetteville, AR 72704
Wk. 479.361.9977 Cell 479.422.0763
Email: carl.d.gales@gmail.com

DESIGNED BY:

APPROVED BY:
CDG

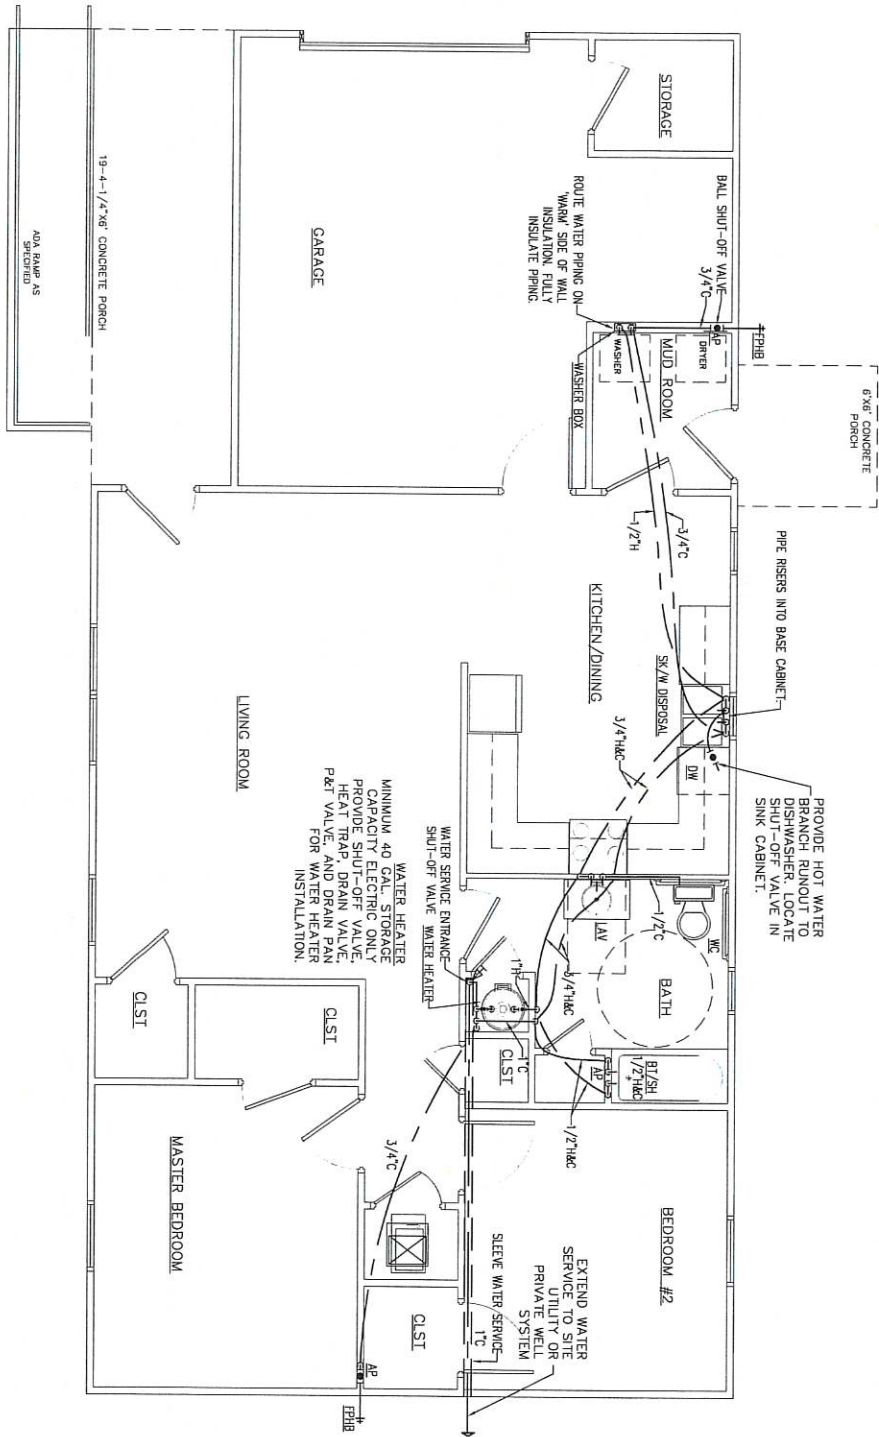

SCALE
3/8" = 1'

SHEET NO.
P102

Cherokee Nation
2 Bedroom Shotgun ADA Left
Garage Domestic Water Plan
1510 Square Feet

CLIENT: Cherokee Nation
Housing Authority

DESIGNED BY:

APPROVED BY:
CDG




ENGINEER

KAS Gales Company
Consulting Engineers

18772 Harmon Road
Fayetteville, AR 72704
Wk. 479.361.9577 Cell 479.422.0763
Email: carl.d.gales@gmail.com

SCALE
3/8" = 1'

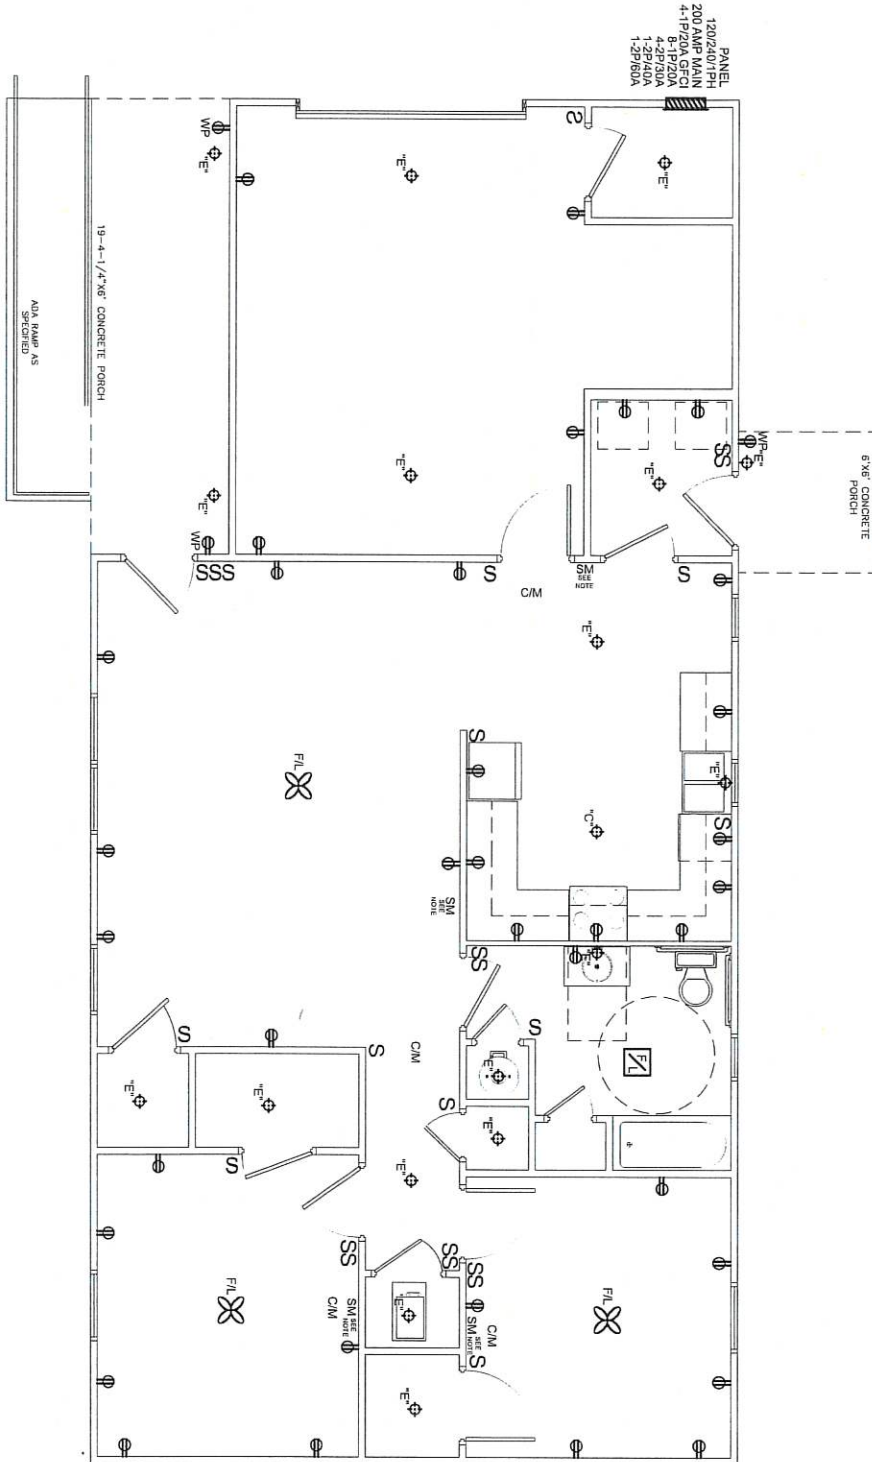

Cherokee Nation
2 Bedroom Shotgun ADA Left
Garage Electrical Plan
1510 Square Feet

CLIENT: Cherokee Nation
Housing Authority



ENGINEER
KAS Gales Company
Consulting Engineers
18772 Harmon Road
Fayetteville, AR 72704
Wk. 479.361.9977 Cell 479.422.0763
Email: carl.d.gales@gmail.com

DESIGNED BY:

APPROVED BY:
CDG

E101
SHEET NO.