



James R. Childers  
Architect, Inc.  
45 South 4th Street  
Fort Smith, AR 72901  
479-783-2450  
www.childersarchitect.com

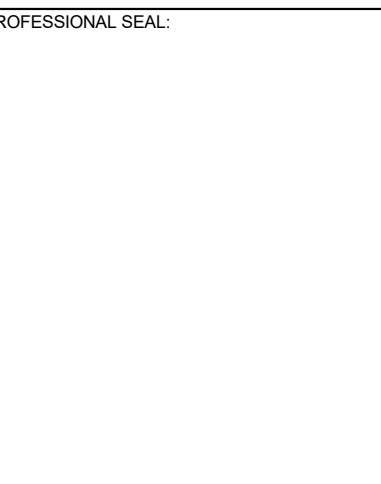

**CHEROKEE NATION**  
**WCCA - REMODEL AND SITE IMPROVEMENTS**  
 395400 W 2600 Rd., Okemah, OK 74051

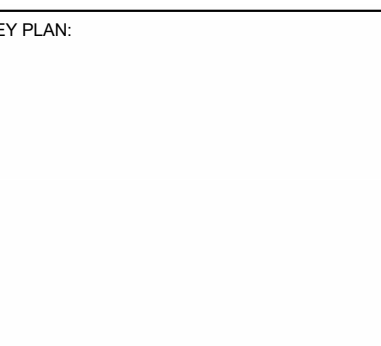

PROJECT PHASE:  
**100% CD's**

#	DATE	REVISIONS DESCRIPTION
1	9/20/2024	Asstenda 01

JOB NUMBER: 24-08.58


DATE: 8/16/2024

SHEET NUMBER:  
**G0.00**

SHEET TITLE:  
COVER SHEET

# CHEROKEE NATION WCCA - REMODEL AND SITE IMPROVEMENTS

100% CD's

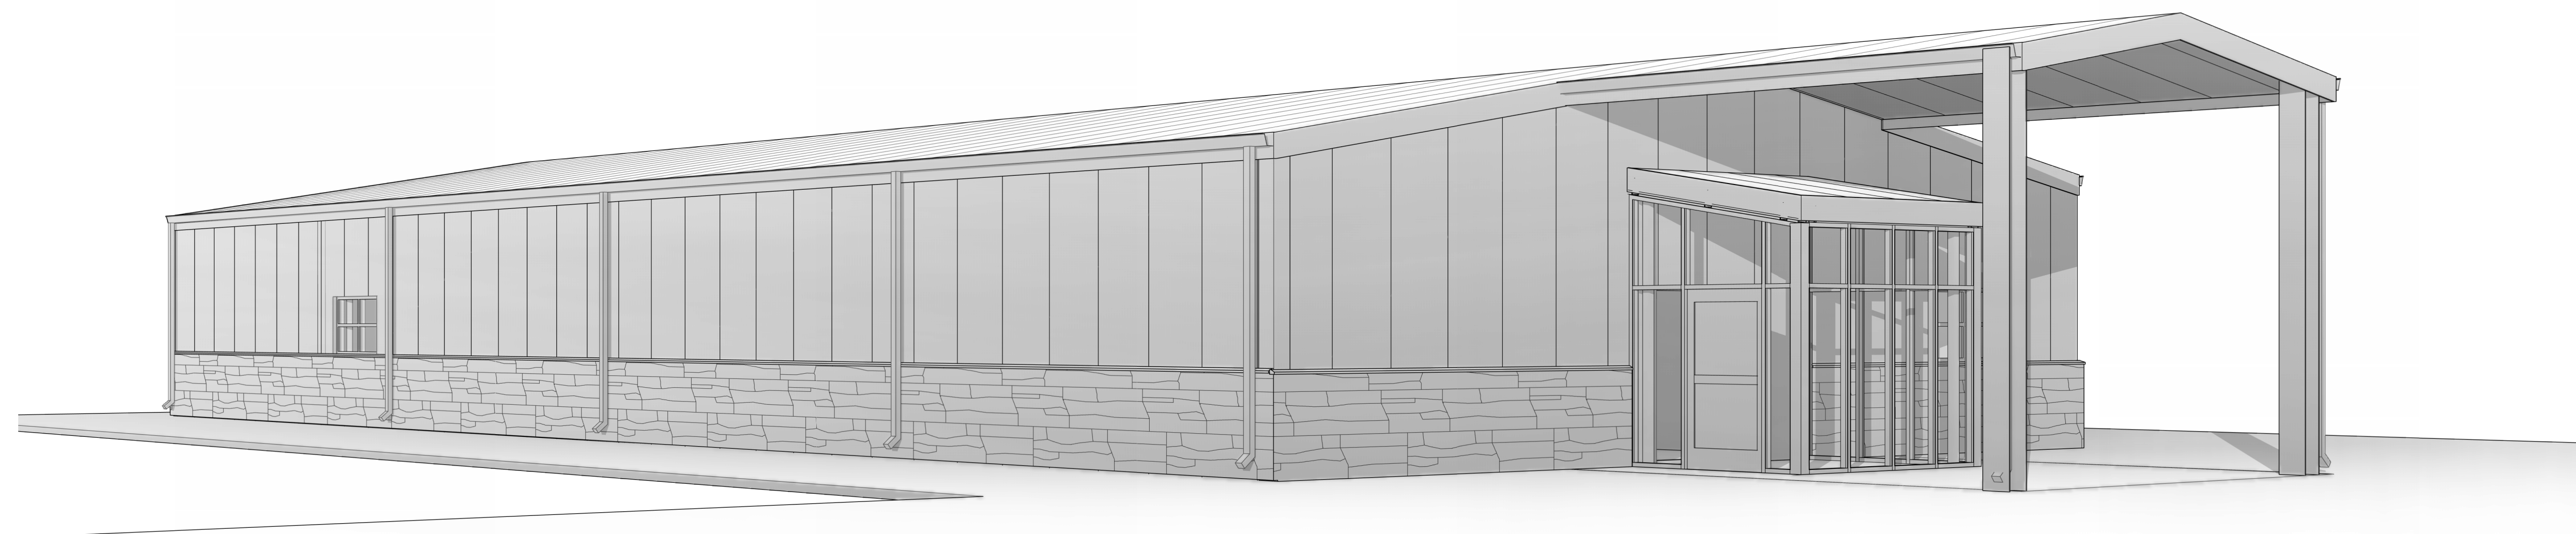

Sheet Number	SHEET NAME	DATE	ADDEN DA #01
INDEX OF DRAWINGS			
8/16/2024 - 100% CONSTRUCTION DOCUMENTS			
9/20/2024			
GENERAL			
G0.00	COVER SHEET		
CIVIL			
C1.00	COVER SHEET		
C2.00	SURVEY 1		
C2.01	SURVEY 2		
C3.00	SITE PLAN AND GRADING		
C4.00	CIVIL DETAILS		
LIFE SAFETY			
L50.00	LIFE SAFETY GENERAL & CODE SUMMARY		
L50.01	LIFE SAFETY PLANS		
ARCHITECTURAL			
A0.01	PROJECT INFORMATION		
A5.00	SITE PLAN		
A1.00	FLOOR PLAN		
A2.00	EXTERIOR ELEVATIONS		
A3.00	WALL SECTIONS AND DETAILS		
A5.00	PARTITION TYPES		
A9.00	ROOF AND CEILING PLAN		
STRUCTURAL			
S0.00	GENERAL NOTES		
S0.01	TYPICAL DETAILS		
S1.01	PLANS		
S2.01	SECTIONS AND DETAILS		
PLUMBING			
P1.1	PLUMBING NOTES, LEGEND, DETAILS, & SCHEDULES		
P2.0	PLUMBING DEMOLITION PLAN		
P2.1	PLUMBING PLAN		
P4.1	PLUMBING RISERS		
MECHANICAL			
M1.1	HVAC NOTES, LEGEND, DETAILS, & SCHEDULES		
M2.0	HVAC DEMOLITION PLAN		
M2.1	HVAC PLAN		
ELECTRICAL			
E1.1	ELECTRICAL LEGEND, NOTES & DETAILS		
E2.0	ELECTRICAL DEMO PLAN		
E2.1	LIGHTING PLAN		
E2.2	POWER PLAN		
E3.0	ELECTRICAL SITE PLAN		
TECHNOLOGY			
T0.00	GENERAL NOTES AND SYMBOLS		
T0.02	RESPONSIBILITY SCHEDULE		
T0.01	SITE PLAN		
T1.01	FLOOR PLAN - LEVEL 01 - SECTOR 01		
T3.01	IDF/ADF PLANS AND ELEVATIONS		
T5.01	DETAILS		
Grand Total: 37			



WALLACE DESIGN COLLECTIVE  
123 N. MARTIN LUTHER KING JR. BLVD  
TULSA, OKLAHOMA 74103  
(918) 584-5898

CIVIL AND STRUCTURAL ENGINEER



HSA ENGINEERING CONSULTING SERVICES, INC.  
7405 ELLIS ST.  
FORT SMITH, AR  
(479) 452-8922

MECHANICAL, ELECTRICAL, PLUMBING



MOBLEY FIRE PROTECTION  
6242 LLANO AVENUE  
DALLAS, TX 75214  
(817) 614-2361

FIRE PROTECTION / LIFE SAFETY



CRUX TECHNOLOGY + SECURITY SOLUTIONS  
401 SOUTH BOSTON AVE, SUITE 500-15  
TULSA, OK 74103  
(800) 685-6440

LOW-VOLTAGE, IT, SECURITY

